



Revised Lighting Plan
PC 02/13/19

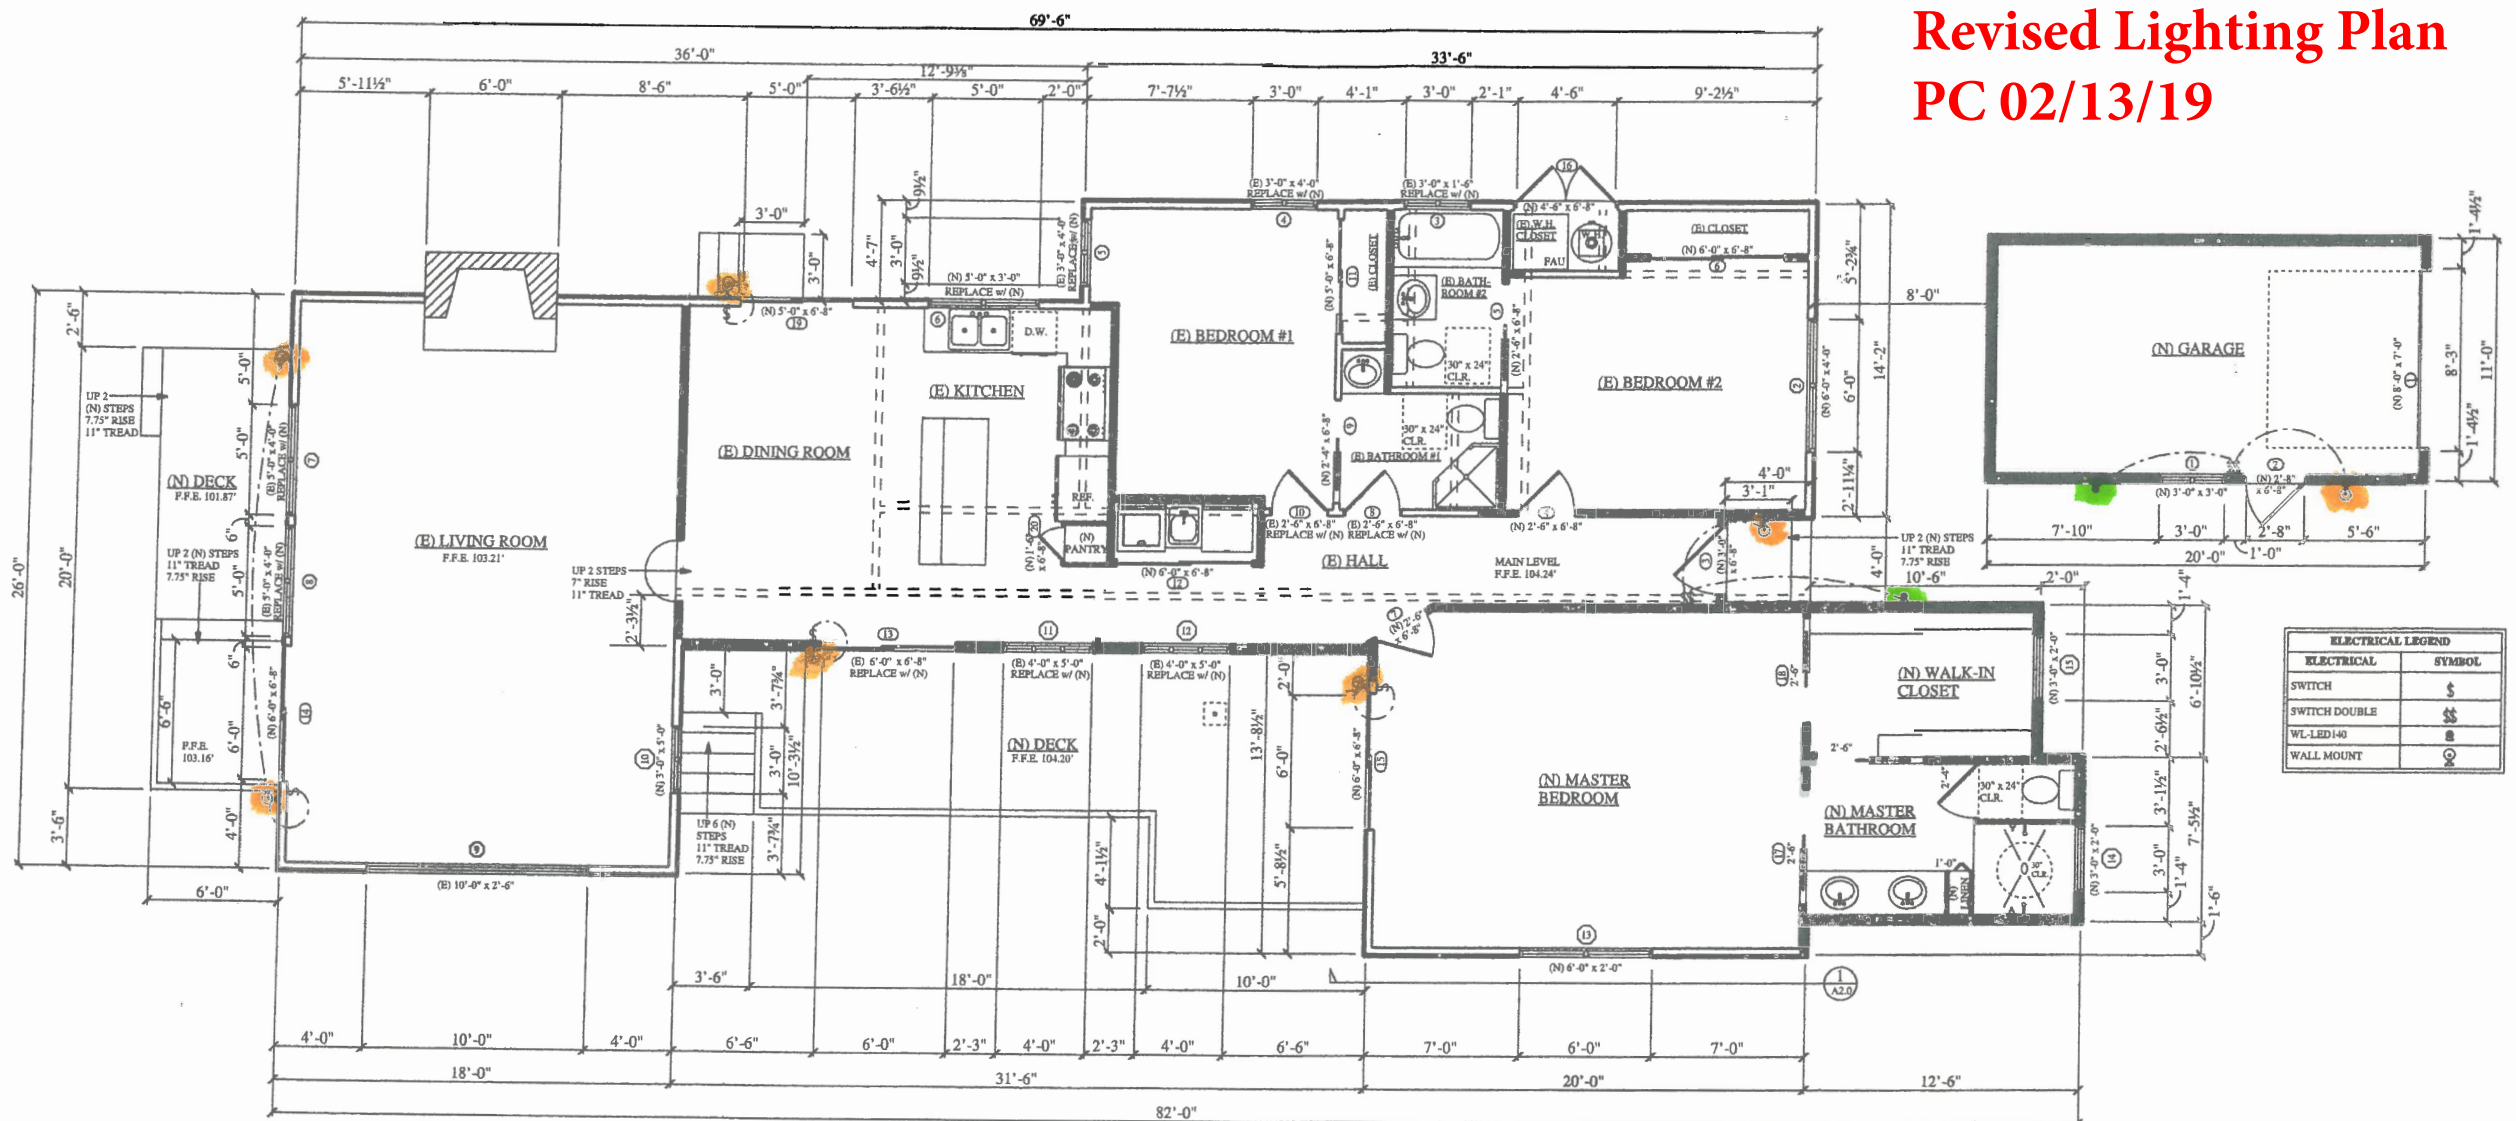


ELECTRICAL LEGEND	
ELECTRICAL	SYMBOL
SWITCH	Ⓢ
SWITCH DOUBLE	ⓈⓈ
WL-LED140	Ⓢ
WALL MOUNT	Ⓢ

PROPOSED FLOOR PLAN
SCALE: 1/4" = 1'-0"

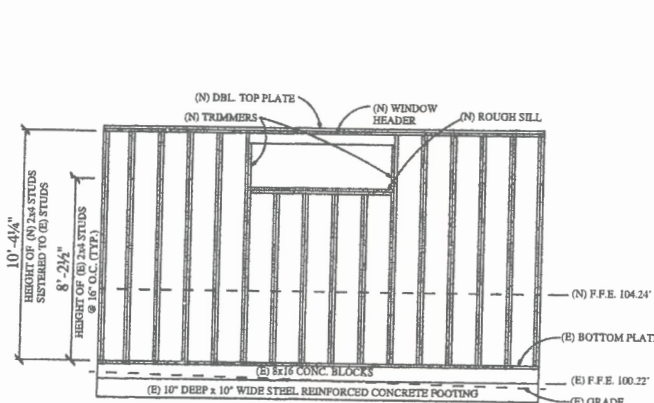

1 PROPOSED WALL FRAMING DETAIL
SCALE: 1/4" = 1'-0"

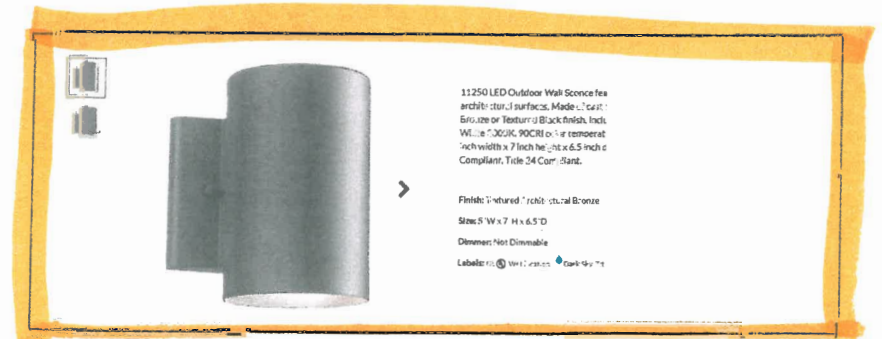

11250 LED Outdoor Wall Sconce
architectural surface. Made of cast
aluminum or stainless steel. Available in
white, black, or bronze. 11250 LED
architectural surface. Made of cast
aluminum or stainless steel. Available in
white, black, or bronze. 11250 LED
architectural surface. Made of cast
aluminum or stainless steel. Available in
white, black, or bronze.

Finish: 11250 LED
Size: 5" W x 7" H x 6.5" D
Dimension: Not Dimensional
Label: 11250 LED



WINDOW OPENING SCHEDULE					
ID	STYLE	SIZE	HINGE DIRECTION	COUNT	TYPE
1	WOOD CASEMENT	(N) 3'-0" x 3'-0"	LR	1	WINDOW
2	WOOD CASEMENT	(N) 6'-0" x 4'-0"	LR	1	EGRESS
3	WOOD CASEMENT	(N) 3'-0" x 1'-6"	LR	1	WINDOW
4	WOOD CASEMENT	(N) 3'-0" x 4'-0"	LR	1	EGRESS
5	WOOD CASEMENT	(N) 3'-0" x 4'-0"	LR	1	WINDOW
6	WOOD CASEMENT	(N) 5'-0" x 3'-0"	LR	1	WINDOW
7	WOOD CASEMENT	(N) 5'-0" x 4'-0"	LR	1	WINDOW
8	WOOD CASEMENT	(N) 10'-0" x 2'-6"	N	1	WINDOW
9	WOOD CASEMENT	(N) 5'-0" x 4'-0"	LR	1	WINDOW
10	WOOD CASEMENT	(N) 3'-0" x 5'-0"	LR	1	WINDOW
11	WOOD CASEMENT	(N) 4'-0" x 5'-0"	LNR	1	LOW-E WINDOW
12	WOOD CASEMENT	(N) 4'-0" x 5'-0"	LNR	1	LOW-E WINDOW
13	WOOD CASEMENT	(N) 6'-0" x 2'-0"	LR	1	LOW-E WINDOW
14	WOOD CASEMENT	(N) 3'-0" x 2'-0"	L	1	LOW-E WINDOW
15	WOOD CASEMENT	(N) 3'-0" x 2'-0"	R	1	LOW-E WINDOW

DOOR OPENING SCHEDULE					
ID	STYLE	SIZE	HINGE DIRECTION	COUNT	TYPE
1	EXT. SECTIONAL GARAGE DOOR	(N) 8'-0" x 7'-0"	U	1	GARAGE
2	EXT. FRENCH DOOR	(N) 3'-0" x 6'-8"	R	1	DOOR
3	EXT. FRENCH DOOR	(N) 3'-0" x 6'-8"	R	1	DOOR
4	INT. SHAKER STYLE ALDER	(N) 2'-4" x 6'-8"	L	1	DOOR
5	INT. SHAKER STYLE ALDER	(N) 2'-4" x 6'-8"	N	1	POCKET
6	INT. SHAKER STYLE ALDER	(N) 6'-0" x 6'-8"	NN	2	BI-PASS
7	INT. SHAKER STYLE ALDER	(N) 2'-4" x 6'-8"	R	1	DOOR
8	INT. SHAKER STYLE ALDER	(N) 2'-4" x 6'-8"	L	1	DOOR
9	INT. SHAKER STYLE ALDER	(N) 2'-4" x 6'-8"	N	1	POCKET
10	INT. SHAKER STYLE ALDER	(N) 2'-4" x 6'-8"	R	1	DOOR
11	INT. SHAKER STYLE ALDER	(N) 2'-4" x 6'-8"	NN	2	BI-PASS
12	INT. SHAKER STYLE ALDER	(N) 3'-0" x 6'-8"	NN	2	BI-PASS
13	EXT. SLIDING GLASS DOOR	(N) 6'-0" x 6'-8"	NN	1	LOW-E
14	EXT. SLIDING GLASS DOOR	(N) 6'-0" x 6'-8"	NN	1	LOW-E
15	EXT. SLIDING GLASS DOOR	(N) 6'-0" x 6'-8"	NN	1	LOW-E
16	EXT. UTILITY DOOR	(N) 2'-0" x 6'-8"	LR	2	DOOR
17	INT. SHAKER STYLE ALDER	(N) 2'-4" x 6'-8"	N	1	POCKET
18	INT. SHAKER STYLE ALDER	(N) 2'-4" x 6'-8"	N	1	POCKET
19	EXT. SLIDING GLASS DOOR	(N) 5'-0" x 6'-8"	N	1	LOW-E
20	INT. PANTRY BUILT-IN	(N) 1'-0" x 6'-8"	L	1	DOOR

DATE: 01/22/2019
JOB NO: 2018-08
DRAWN BY: KAS
REVISIONS

CONTRACTOR
FERRANTE/BENECH
CUSTOM BUILDERS, INC.
P.O. BOX 143
CARMEL VALLEY, CA 93924
TEL: 831-659-3220

STRUCTURAL ENGINEER

PLANS PREPARED BY:

Blackwell
DESIGN CONSULTANTS
PO BOX 81
CARMEL VALLEY, CA 93924
TEL: 831-233-2266

PROPOSED INTERIOR REMODEL
AND ADDITION FOR:

DON AND ALICE BROWN
VIZCAINO, 6 SW OF MOUNTAIN VIEW
CARMEL, CA 93921
TEL: 650-326-7976


APN: 010-055-027-000

SHEET:

A2.0


OF 8

Original Lighting Plan
PC 01/16/19


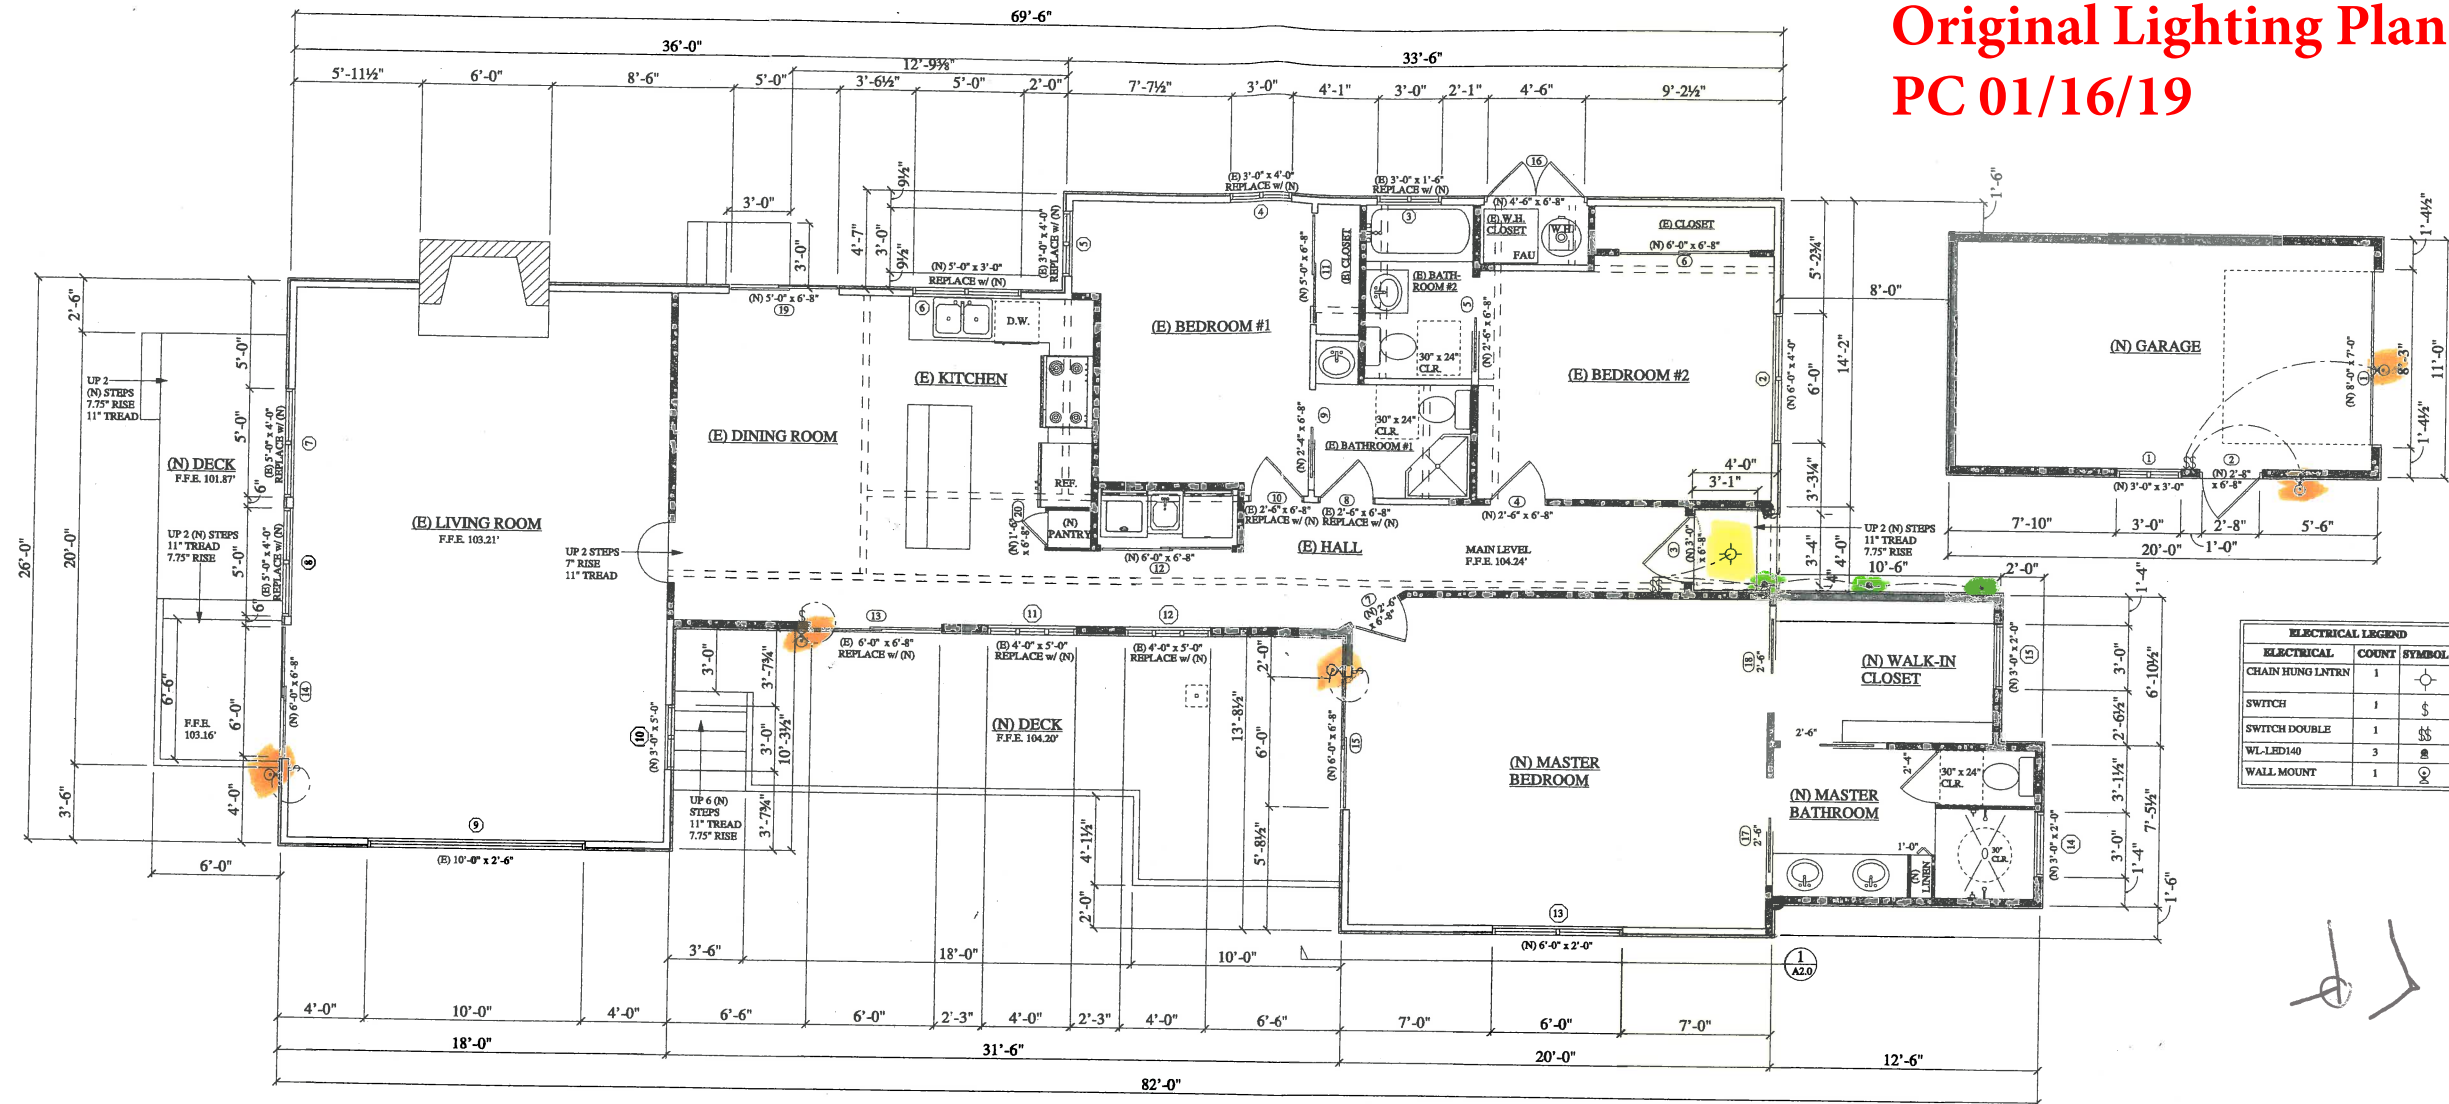


ELECTRICAL LEGEND		
ELECTRICAL	COUNT	SYMBOL
CHAIN HUNG LITRN	1	
SWITCH	1	
SWITCH DOUBLE	1	
WL-LED140	3	
WALL MOUNT	1	

PROPOSED FLOOR PLAN
SCALE: 1/4" = 1'-0"

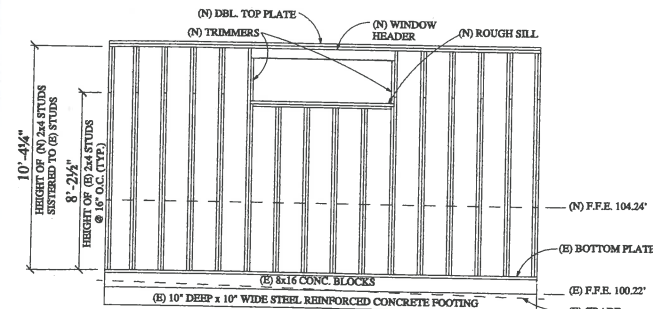

1 PROPOSED WALL FRAMING DETAIL
SCALE: 1/4" = 1'-0"

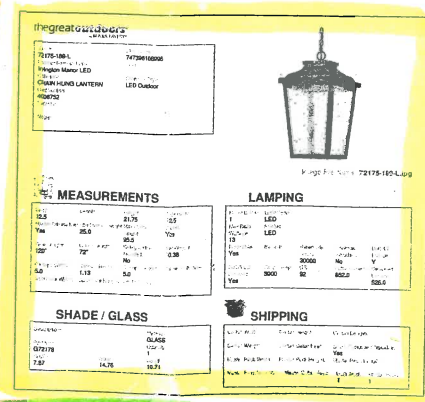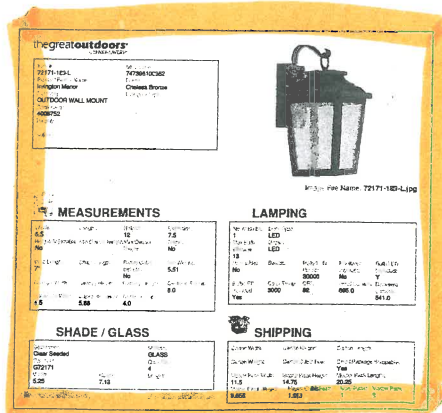

WINDOW OPENING SCHEDULE					
ID	STYLE	SIZE	HINGE DIRECTION	COUNT	TYPE
1	WOOD CASEMENT	(N) 3'-0" x 3'-0"	LR	1	WINDOW
2	WOOD CASEMENT	(N) 6'-0" x 4'-0"	LR	1	EGRESS
3	WOOD CASEMENT	(N) 3'-0" x 1'-6"	LR	1	WINDOW
4	WOOD CASEMENT	(N) 3'-0" x 4'-0"	LR	1	EGRESS
5	WOOD CASEMENT	(N) 3'-0" x 4'-0"	LR	1	WINDOW
6	WOOD CASEMENT	(N) 5'-0" x 3'-0"	LR	1	WINDOW
7	WOOD CASEMENT	(N) 5'-0" x 4'-0"	LR	1	WINDOW
8	WOOD CASEMENT	(N) 10'-0" x 2'-6"	N	1	WINDOW
9	WOOD CASEMENT	(N) 5'-0" x 4'-0"	LR	1	WINDOW
10	WOOD CASEMENT	(N) 3'-0" x 5'-0"	LR	1	WINDOW
11	WOOD CASEMENT	(N) 4'-0" x 5'-0"	LNR	1	LOW-E WINDOW
12	WOOD CASEMENT	(N) 4'-0" x 5'-0"	LNR	1	LOW-E WINDOW
13	WOOD CASEMENT	(N) 6'-0" x 2'-0"	L	1	LOW-E WINDOW
14	WOOD CASEMENT	(N) 3'-0" x 2'-0"	LR	1	LOW-E WINDOW
15	WOOD CASEMENT	(N) 3'-0" x 2'-0"	R	1	LOW-E WINDOW

DOOR OPENING SCHEDULE					
ID	STYLE	SIZE	HINGE DIRECTION	COUNT	TYPE
1	EXT. SECTIONAL GARAGE DOOR	(N) 8'-0" x 7'-0"	U	1	GARAGE
2	EXT. FRENCH DOOR	(N) 2'-8" x 6'-8"	R	1	DOOR
3	EXT. FRENCH DOOR	(N) 3'-0" x 6'-8"	R	1	DOOR
4	INT. SHAKER STYLE ALDER	(N) 2'-6" x 6'-8"	L	1	DOOR
5	INT. SHAKER STYLE ALDER	(N) 2'-6" x 6'-8"	N	1	POCKET
6	INT. SHAKER STYLE ALDER	(N) 6'-0" x 6'-8"	NN	2	BI-PASS
7	INT. SHAKER STYLE ALDER	(N) 2'-6" x 6'-8"	R	1	DOOR
8	INT. SHAKER STYLE ALDER	(N) 2'-6" x 6'-8"	L	1	DOOR
9	INT. SHAKER STYLE ALDER	(N) 2'-4" x 6'-8"	N	1	POCKET
10	INT. SHAKER STYLE ALDER	(N) 2'-4" x 6'-8"	R	1	DOOR
11	INT. SHAKER STYLE ALDER	(N) 2'-6" x 6'-8"	NN	2	BI-PASS
12	INT. SHAKER STYLE ALDER	(N) 2'-6" x 6'-8"	NN	2	BI-PASS
13	EXT. SLIDING GLASS DOOR	(N) 6'-0" x 6'-8"	NN	1	LOW-E
14	EXT. SLIDING GLASS DOOR	(N) 6'-0" x 6'-8"	NN	1	LOW-E
15	EXT. SLIDING GLASS DOOR	(N) 6'-0" x 6'-8"	NN	1	LOW-E
16	EXT. UTILITY DOOR	(N) 2'-3" x 6'-8"	LR	2	DOOR
17	INT. SHAKER STYLE ALDER	(N) 2'-6" x 6'-8"	N	1	POCKET
18	INT. SHAKER STYLE ALDER	(N) 2'-6" x 6'-8"	N	1	POCKET
19	EXT. SLIDING GLASS DOOR	(N) 5'-0" x 6'-8"	N	1	LOW-E
20	INT. PANTRY BUILT-IN	(N) 1'-4" x 6'-8"	L	1	DOOR

PROPOSED INTERIOR REMODEL
AND ADDITION FOR:

DON AND ALICE BROWN
VIZCAINO, 6 SW OF MOUNTAIN VIEW
CARMEL, CA 93921
TEL: 650-326-7976

APN: 010-055-027-000

SHEET:

A2.0